




GROUND FLOOR PLAN FOR TYPICAL TOILET DETAIL (BLOCK - A)

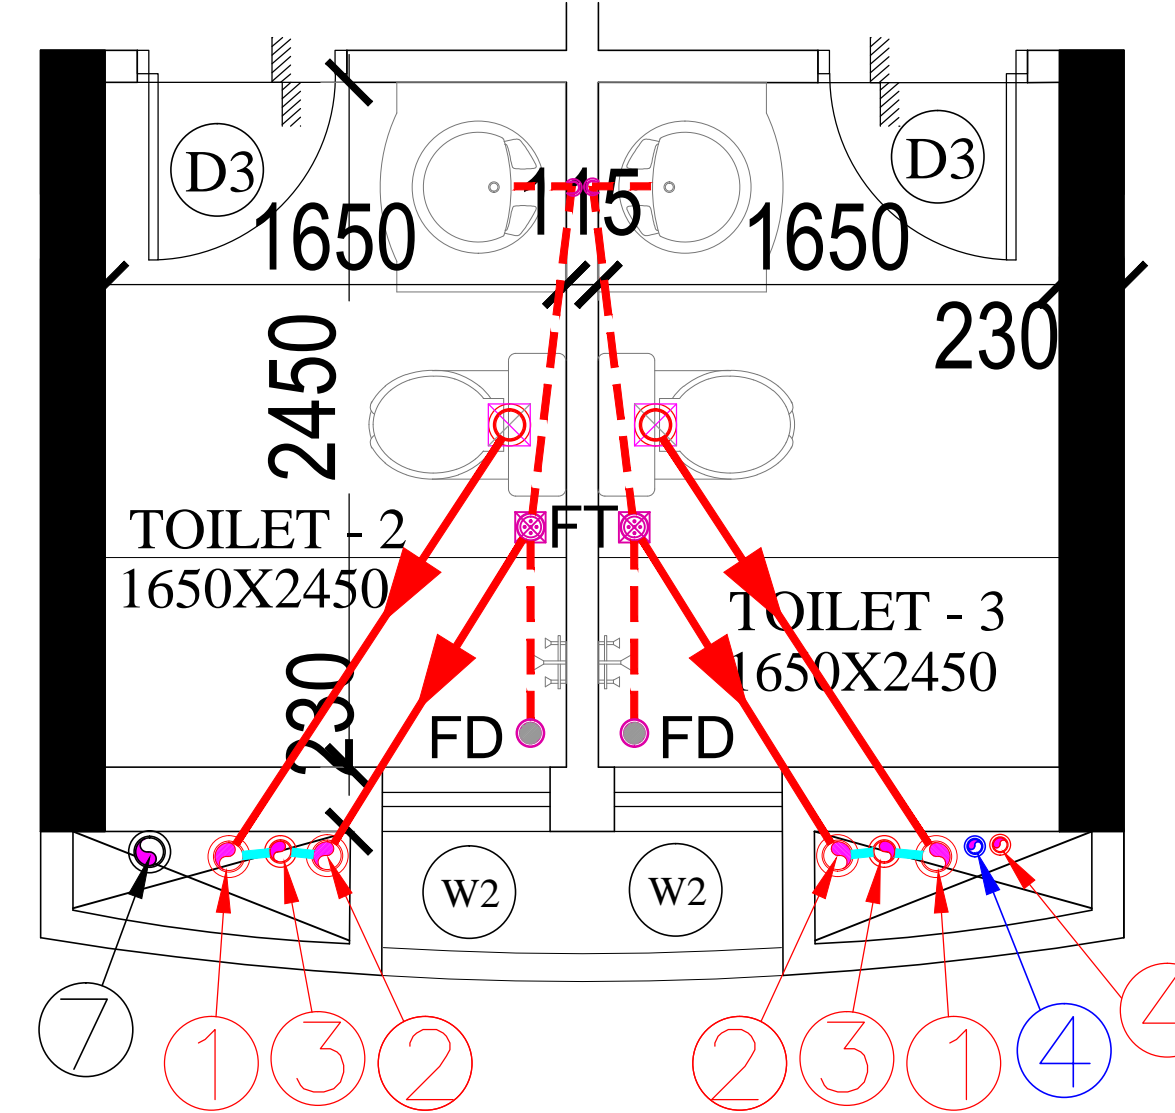


GROUND FLOOR PLAN FOR TYPICAL TOILET DETAIL (BLOCK - A)

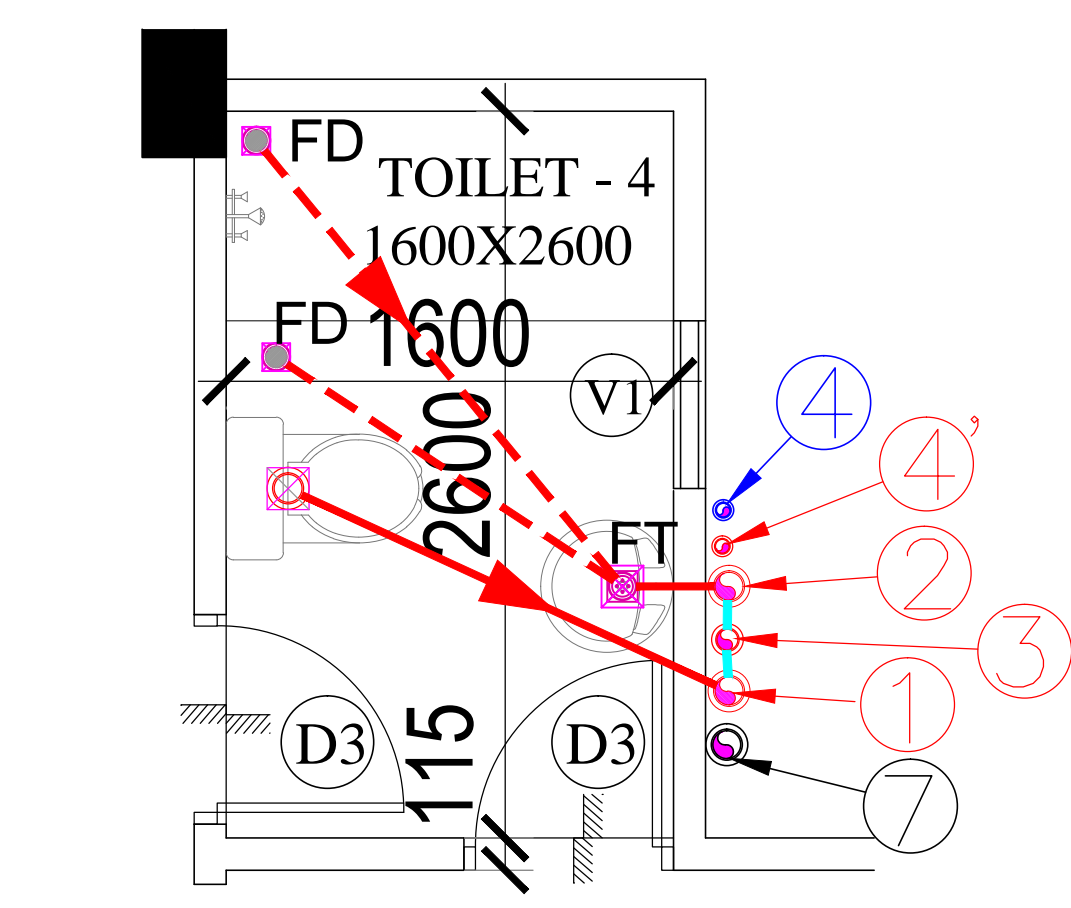


GROUND FLOOR PLAN FOR TYPICAL TOILET DETAIL (BLOCK - A)

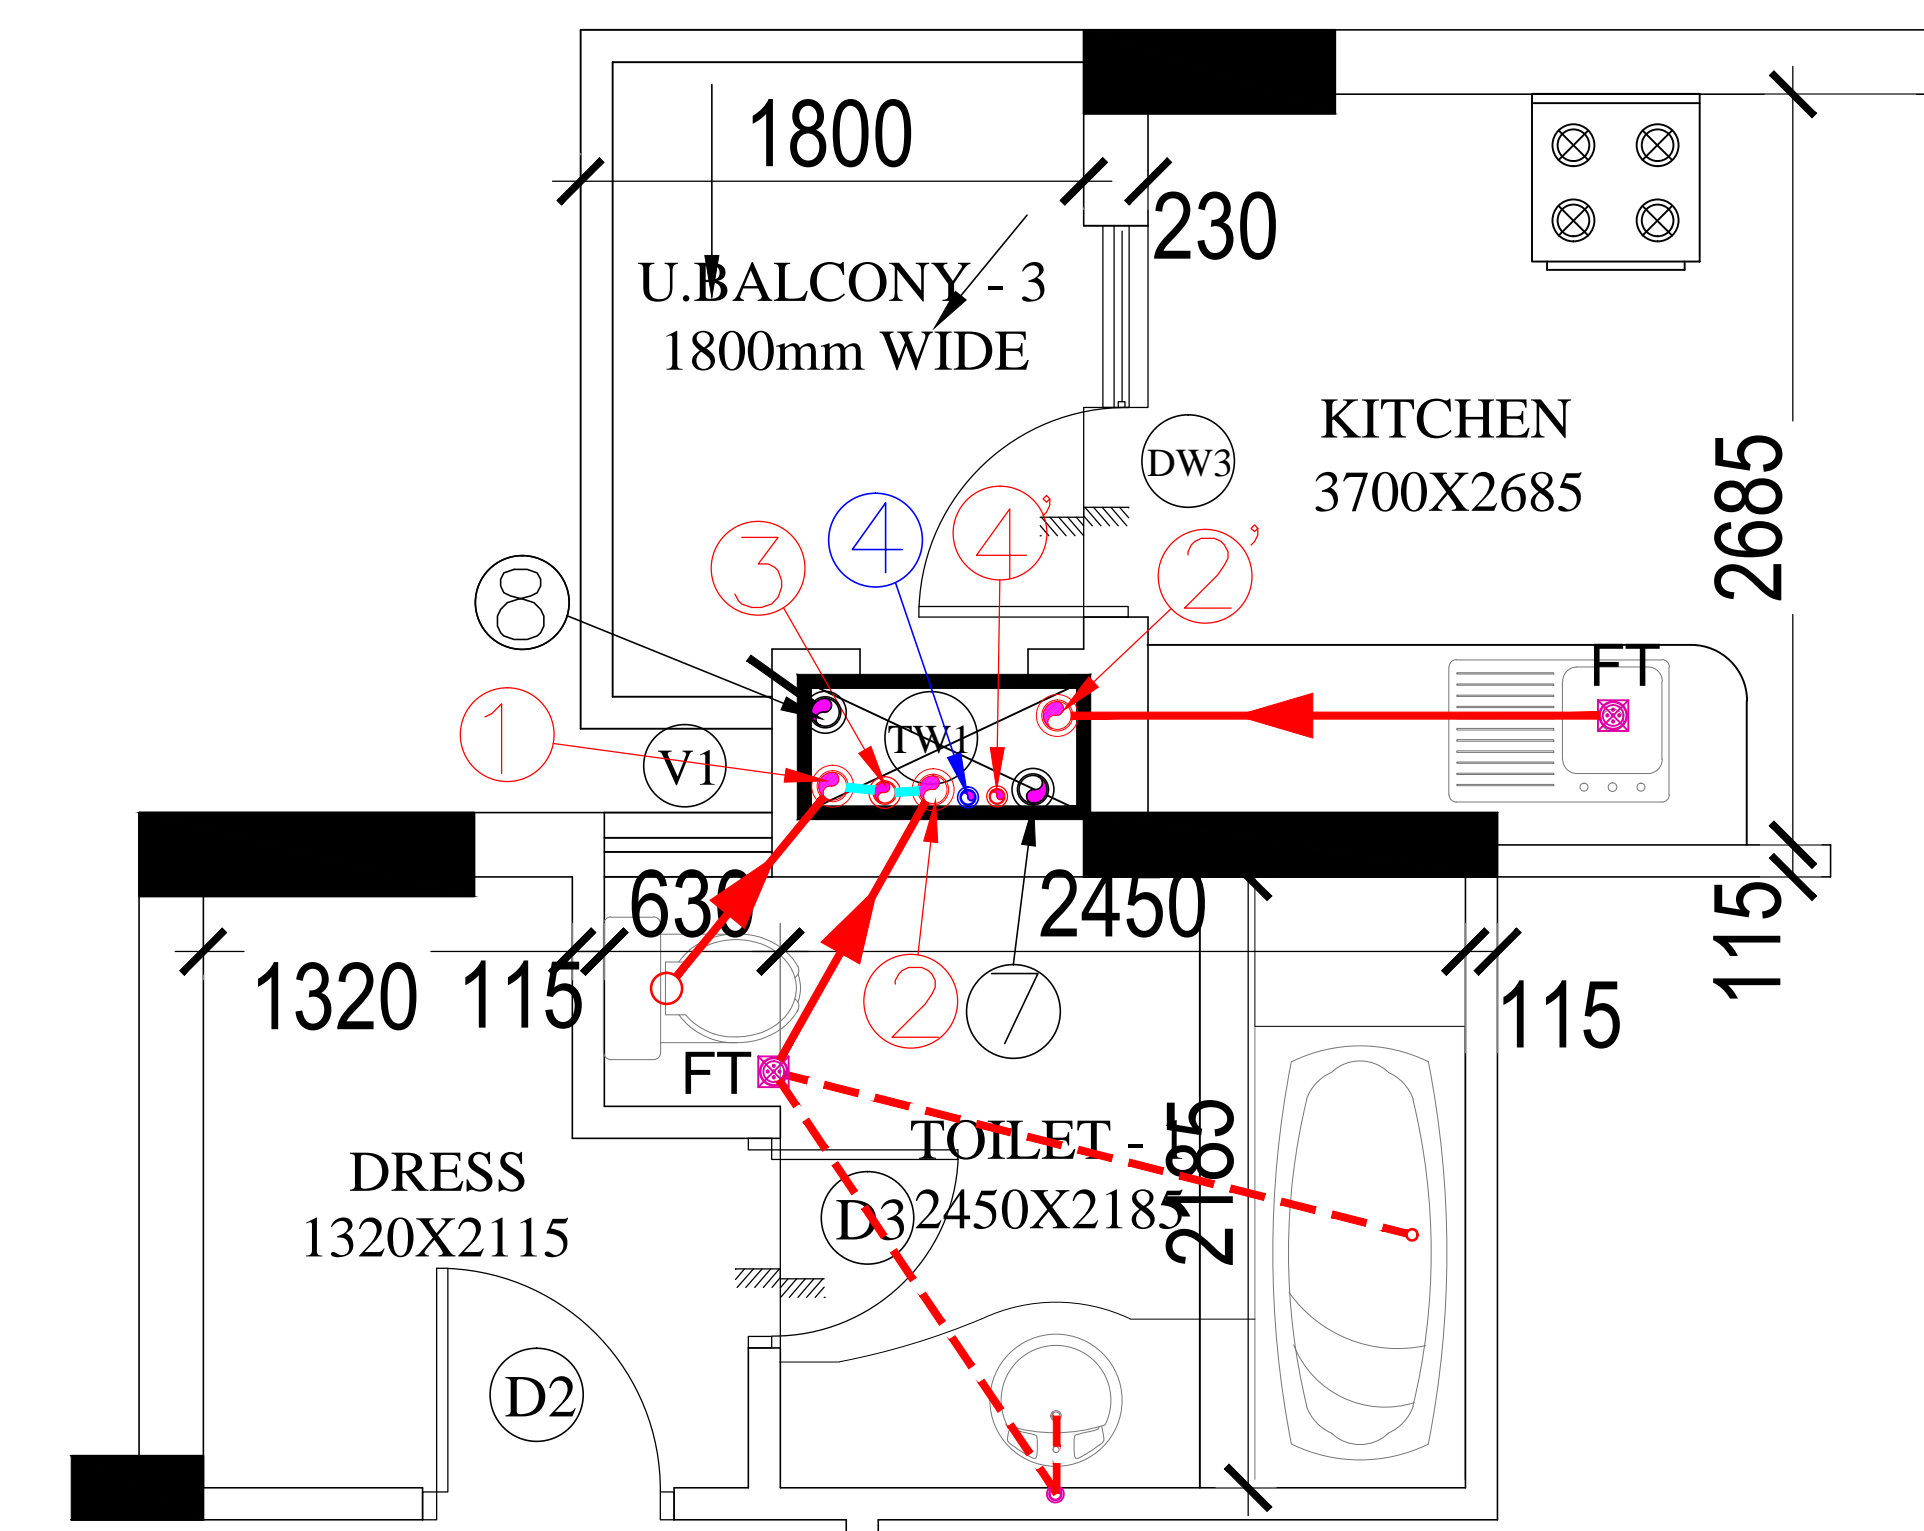


TYPICAL FLOOR PLAN FOR TOILET DETAIL (BLOCK - A)

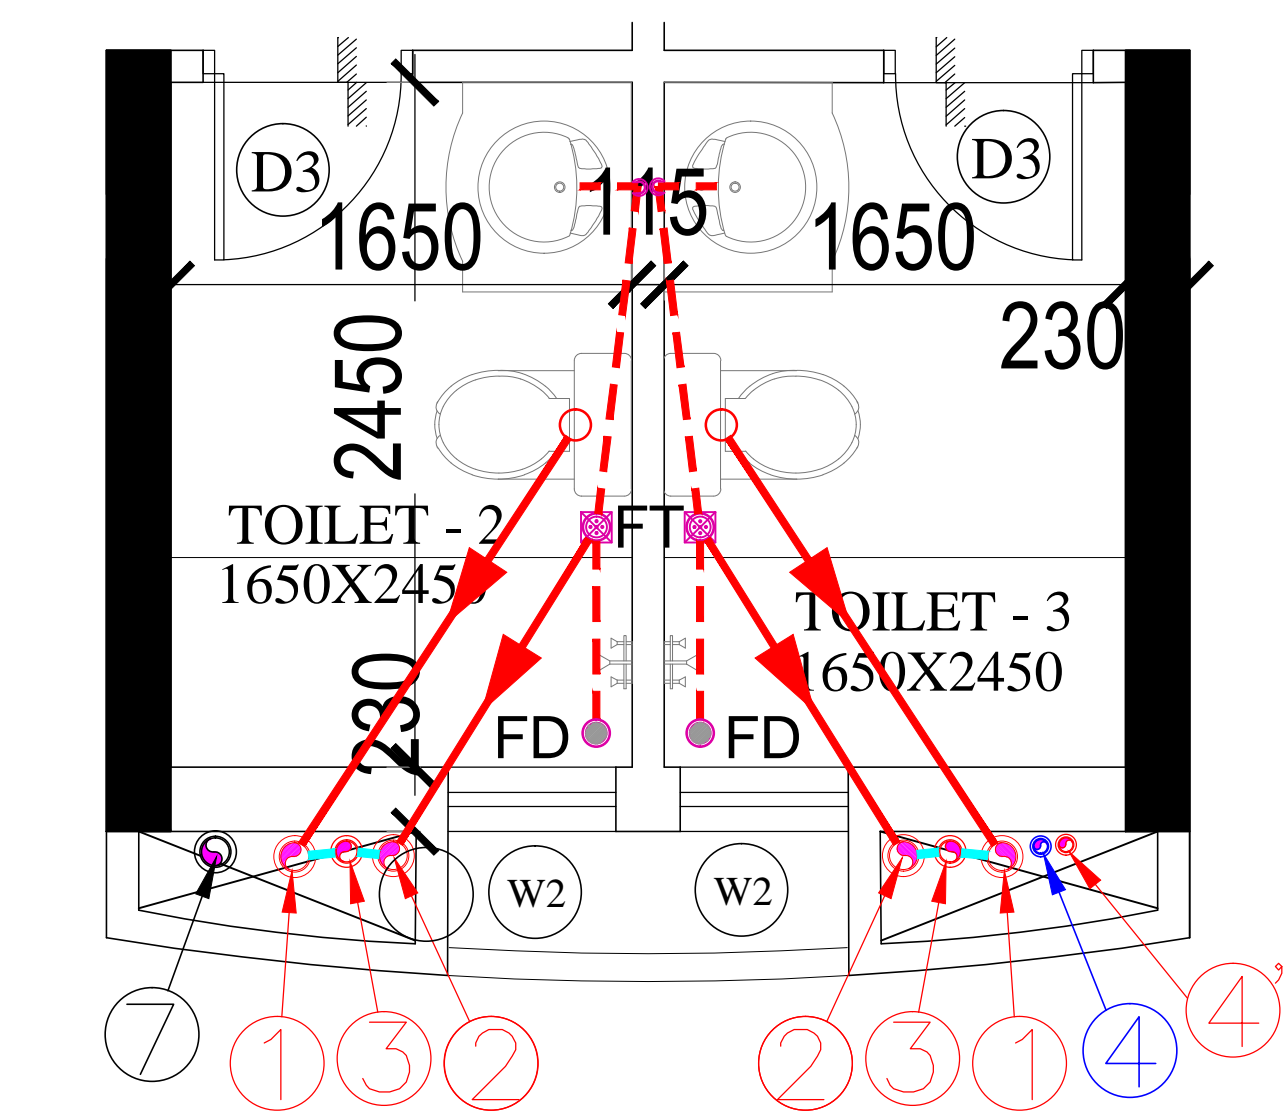


TYPICAL FLOOR PLAN FOR TOILET DETAIL (BLOCK - A)

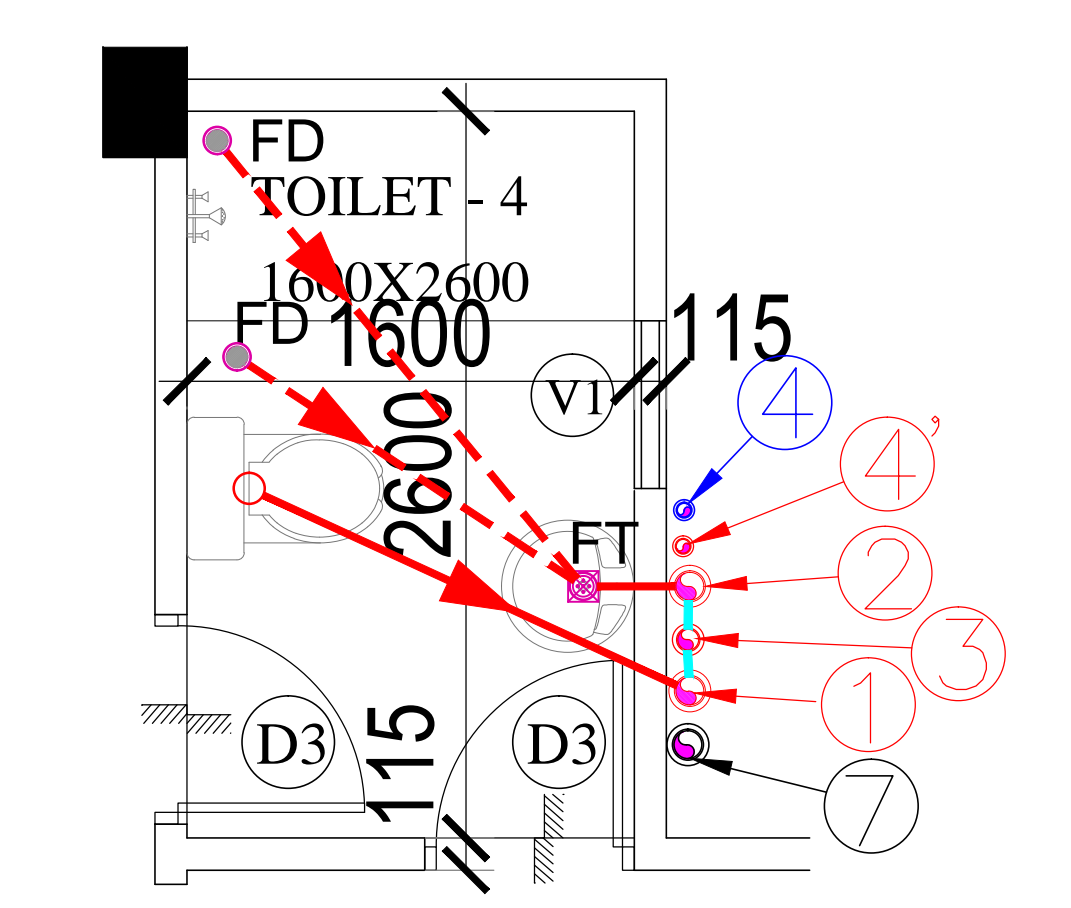


TYPICAL FLOOR PLAN FOR TOILET DETAIL (BLOCK - A)

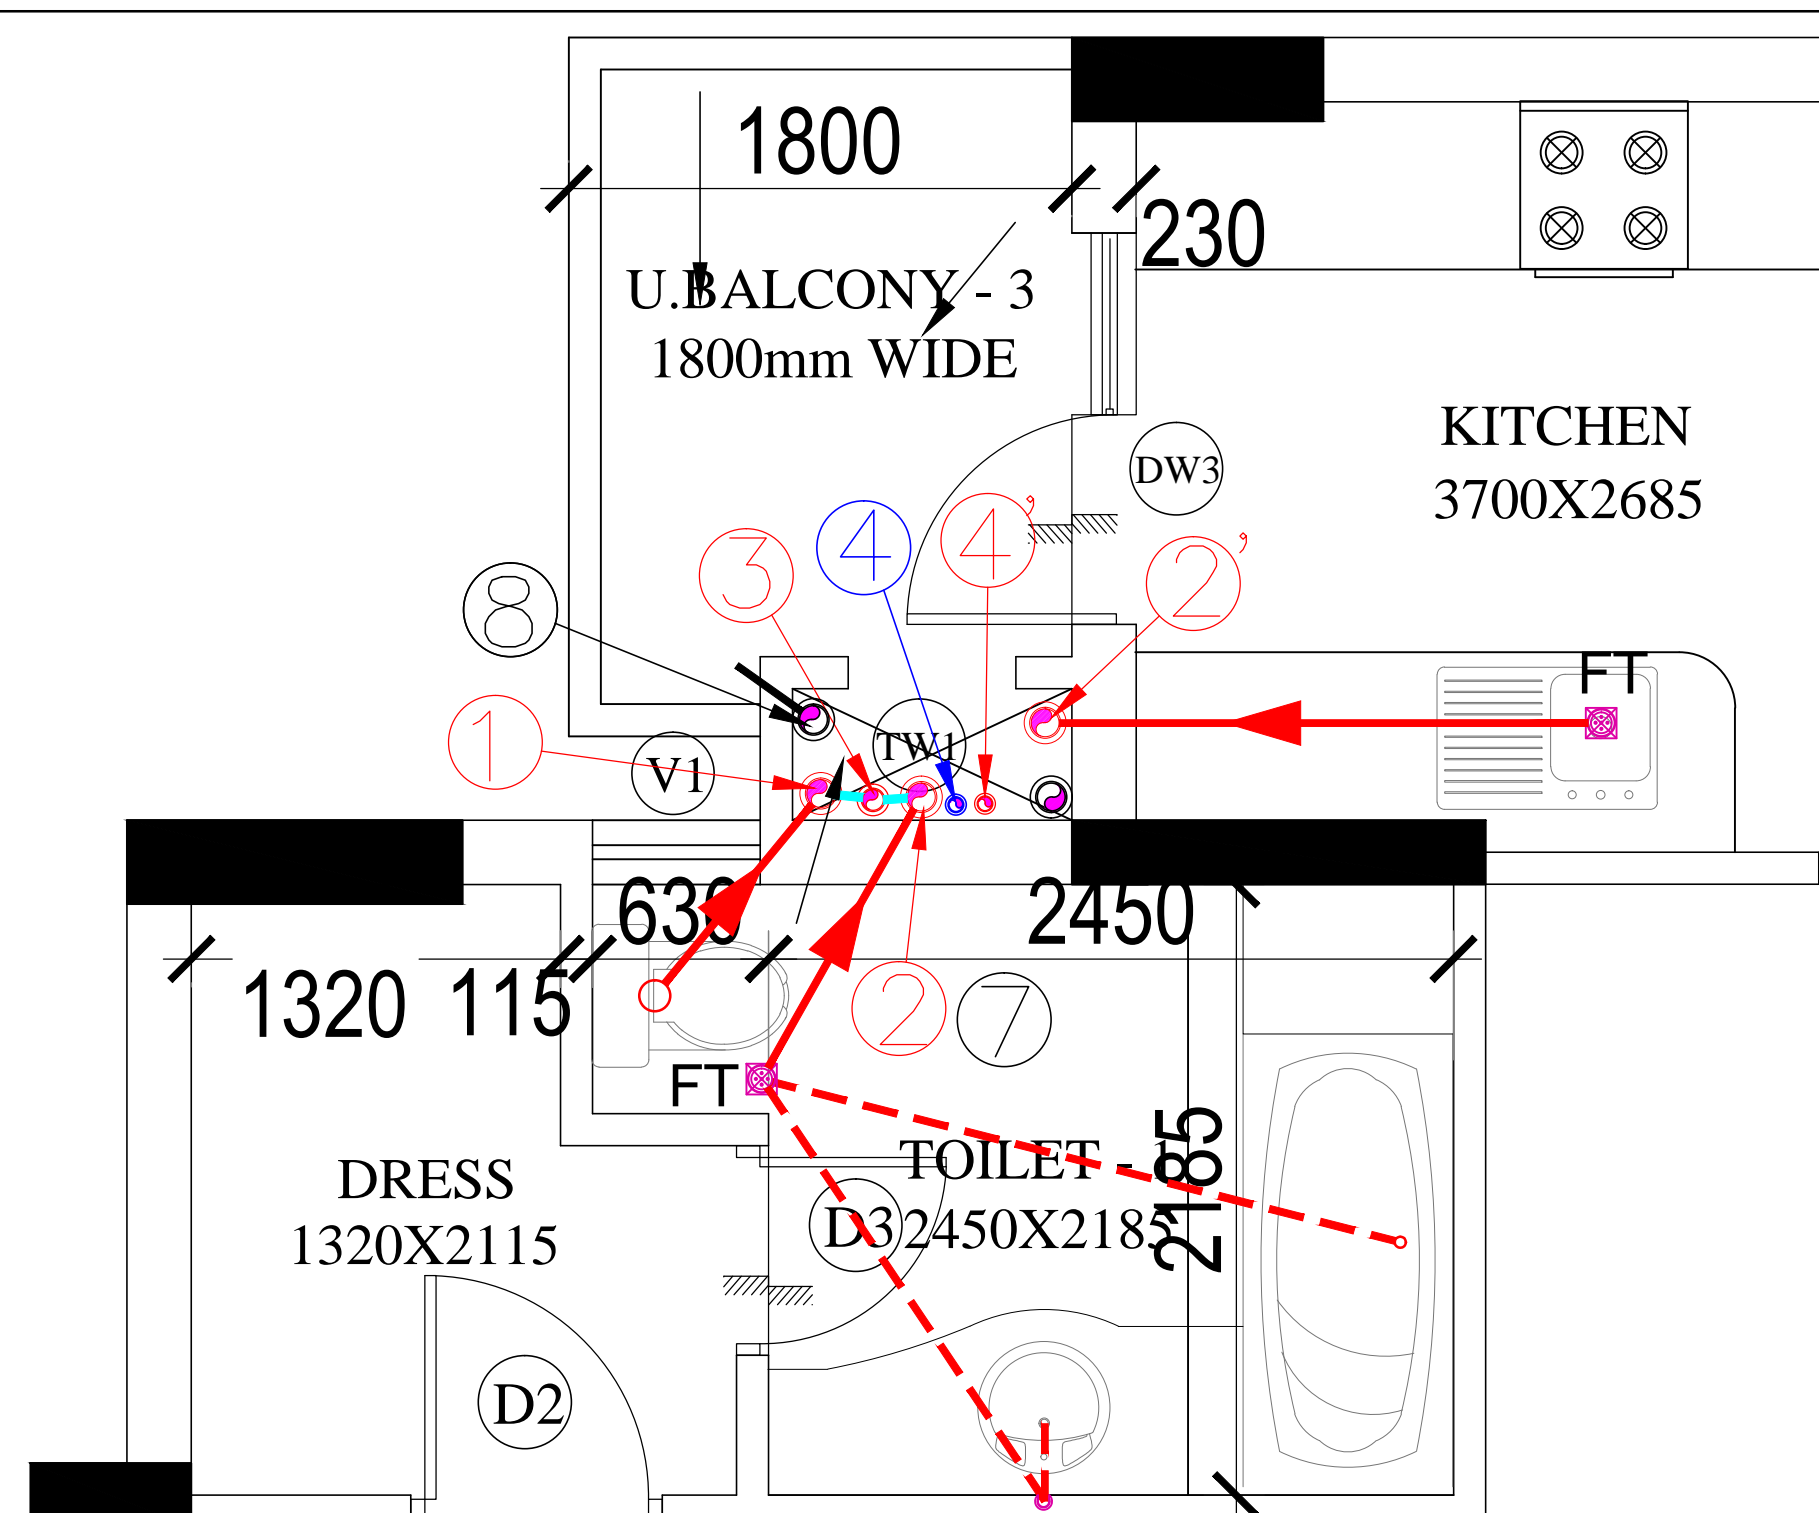


FOURTH FLOOR PLAN FOR TYPICAL TOILET DETAIL (BLOCK - A)

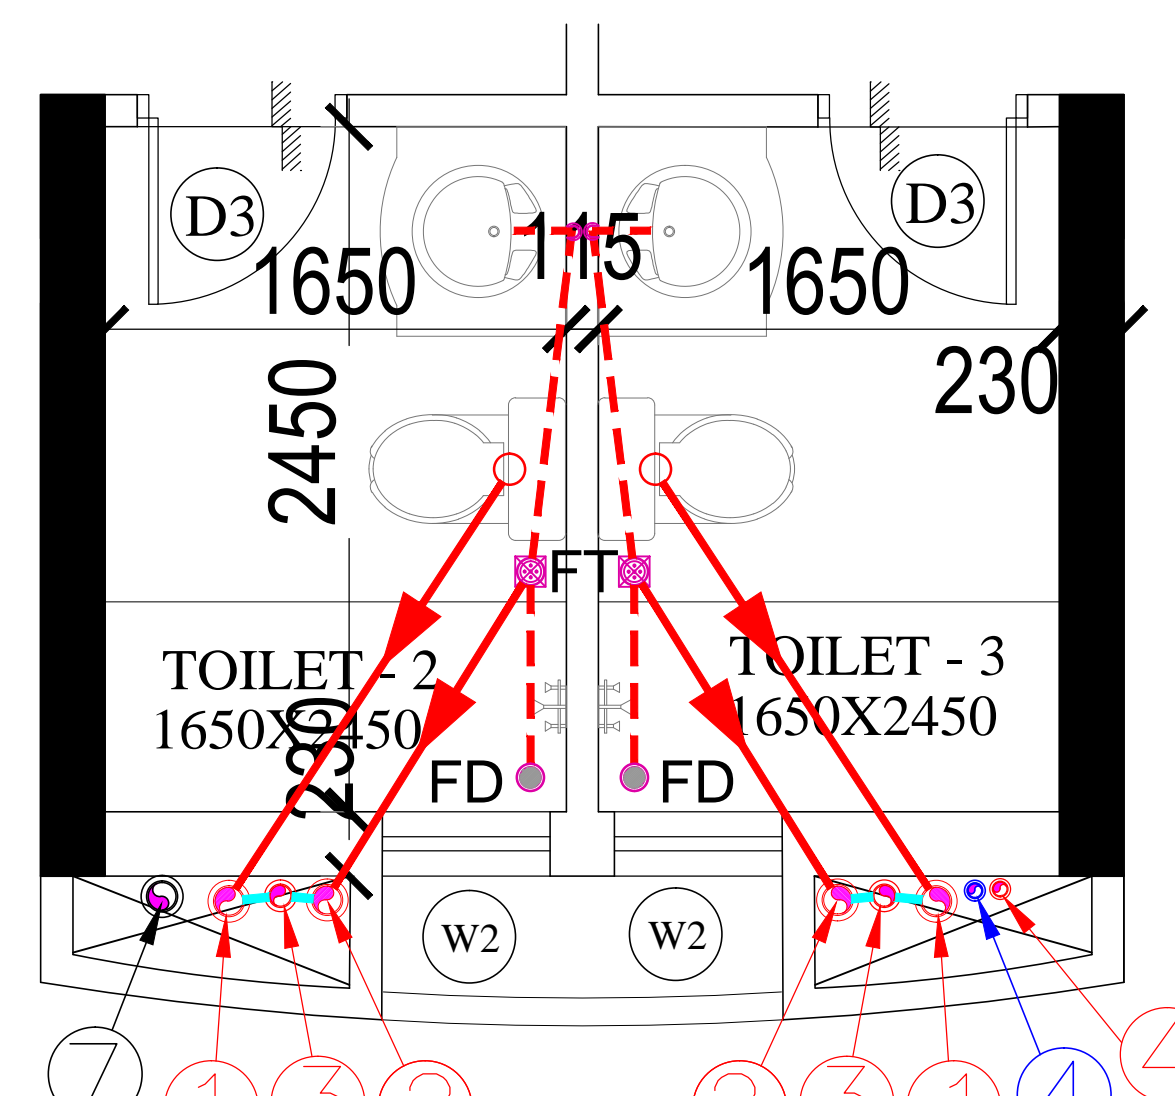


FOURTH FLOOR PLAN FOR TYPICAL TOILET DETAIL (BLOCK - A)

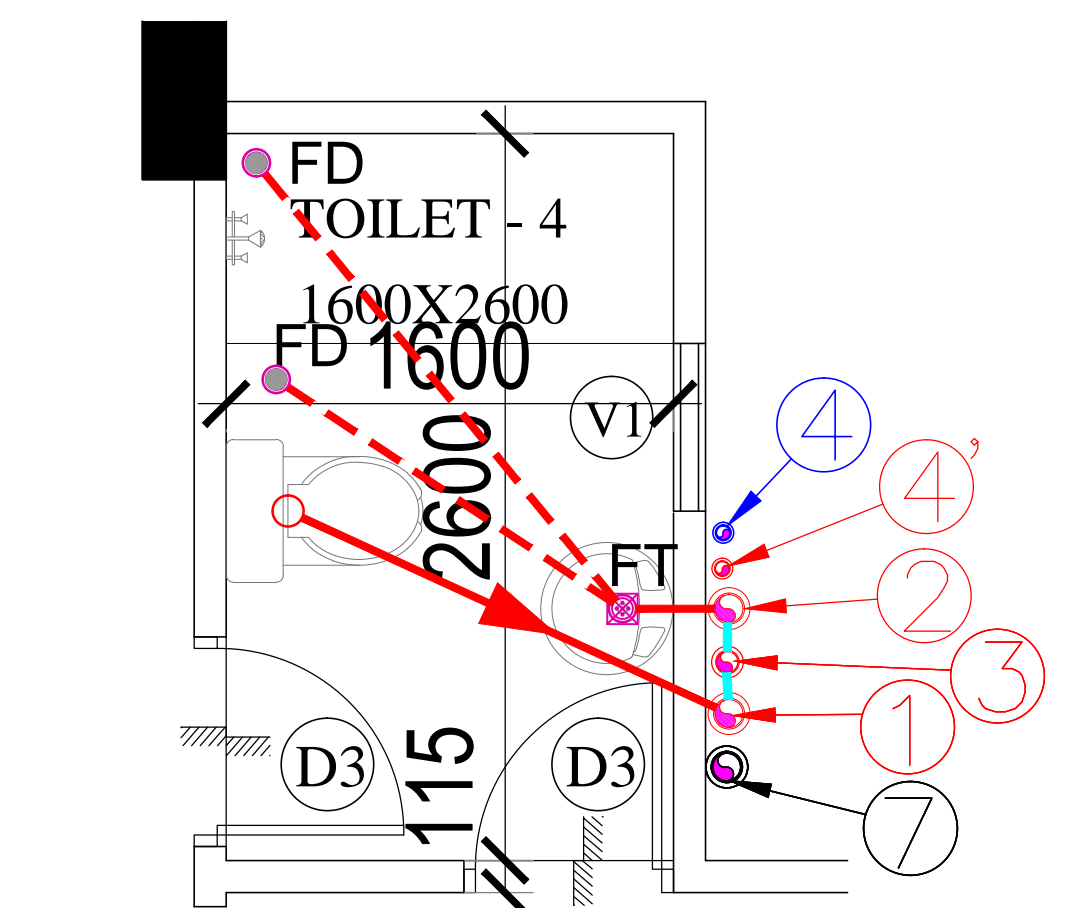


FOURTH FLOOR PLAN FOR TYPICAL TOILET DETAIL (BLOCK - A)

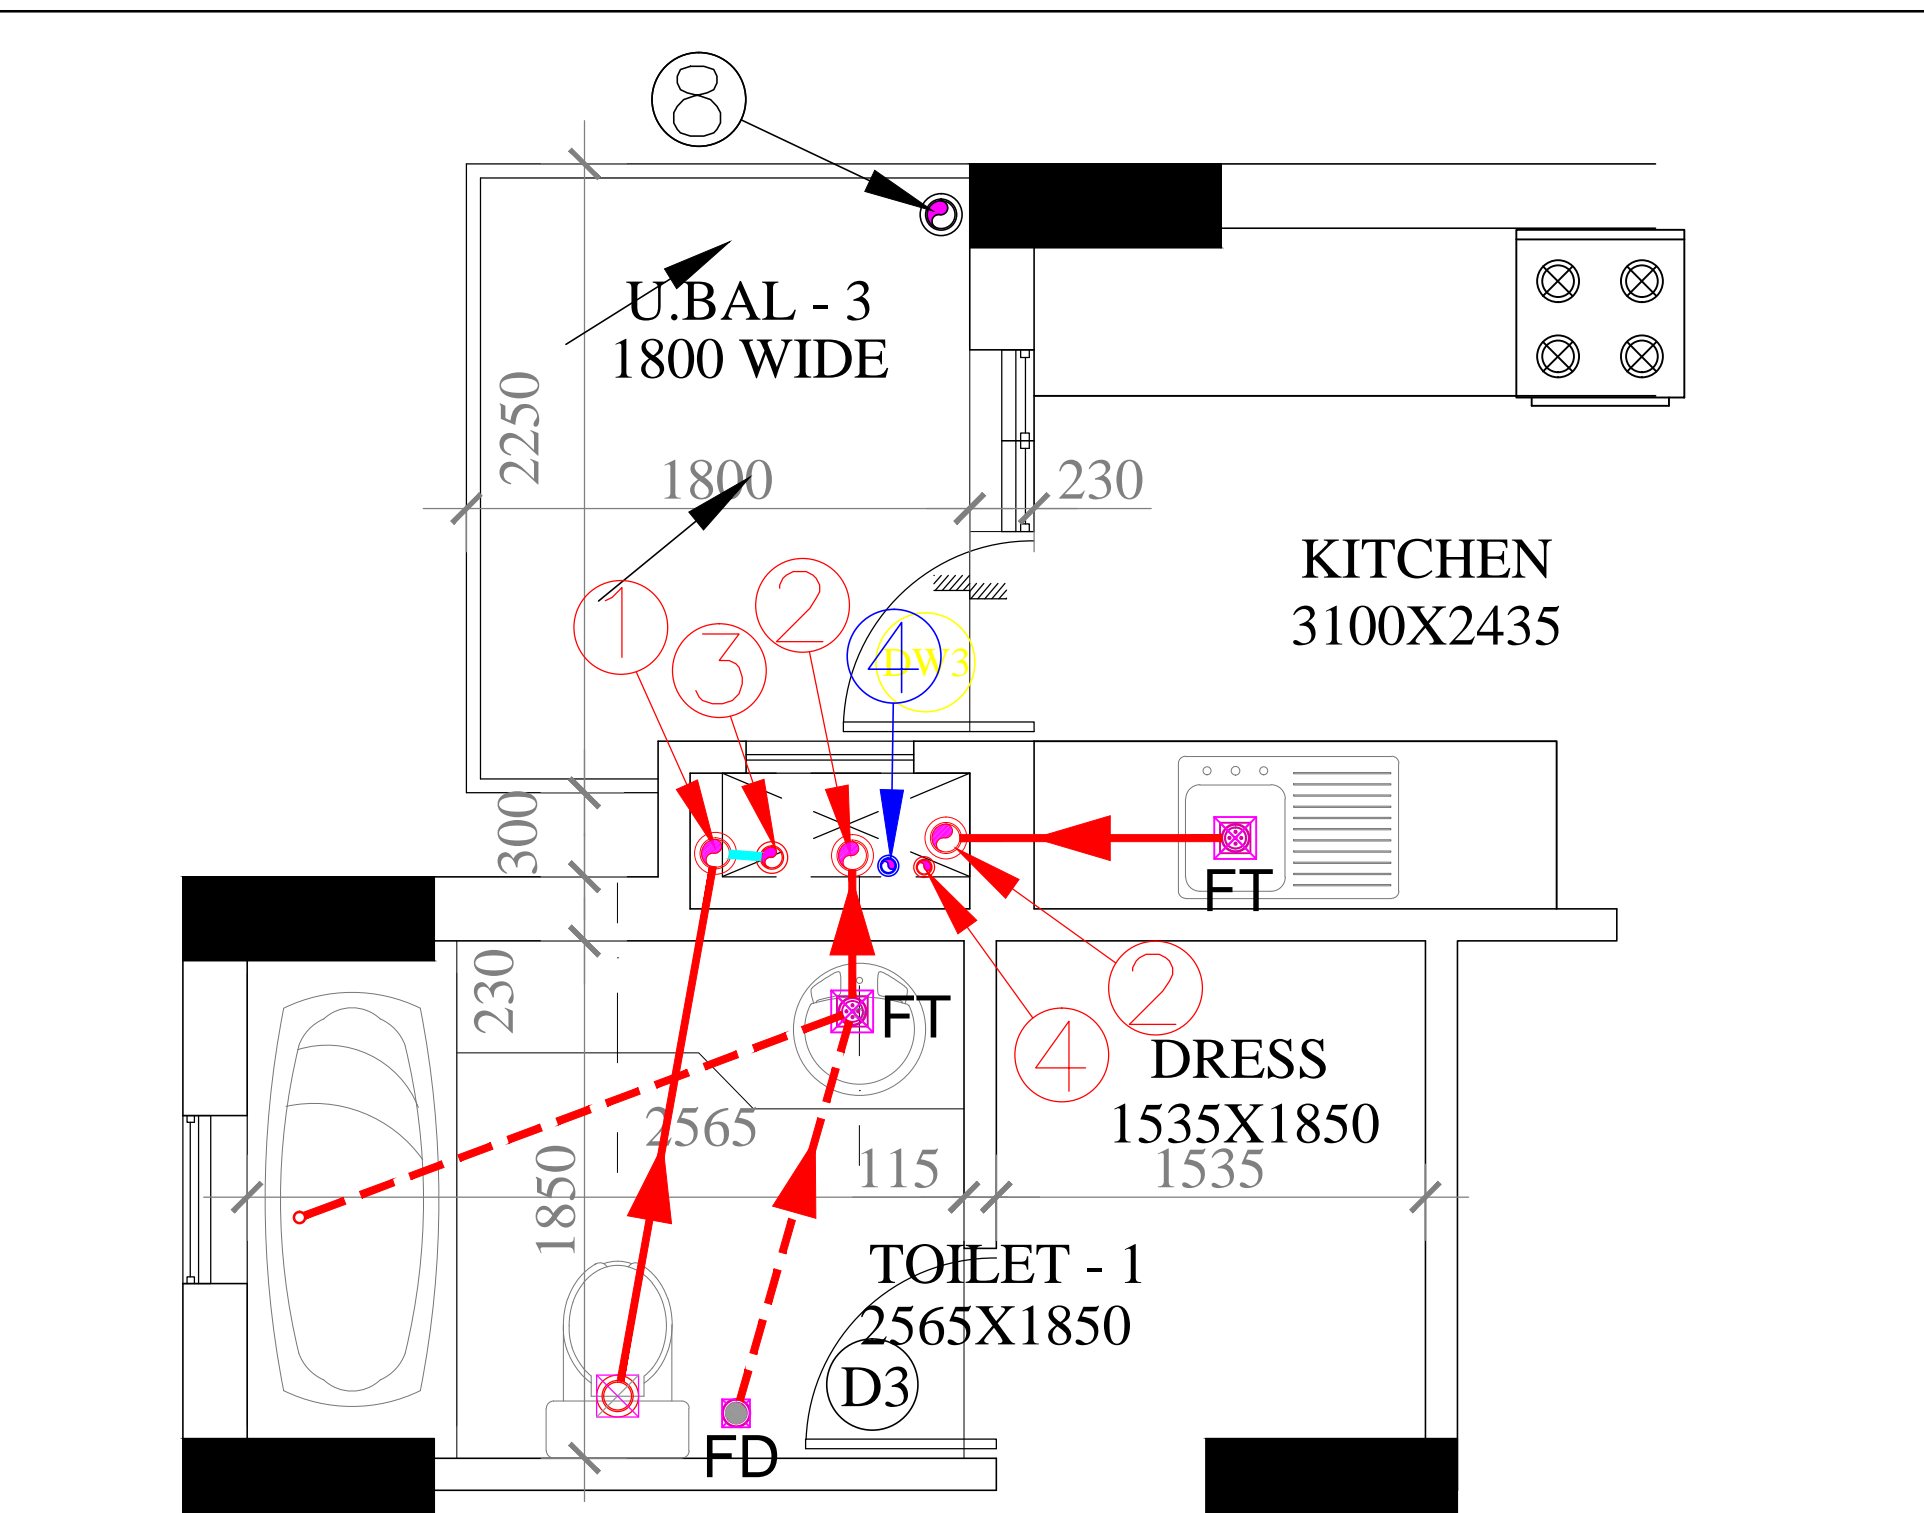


GROUND FLOOR PLAN FOR TYPICAL TOILET DETAIL (BLOCK - B1 & B3)

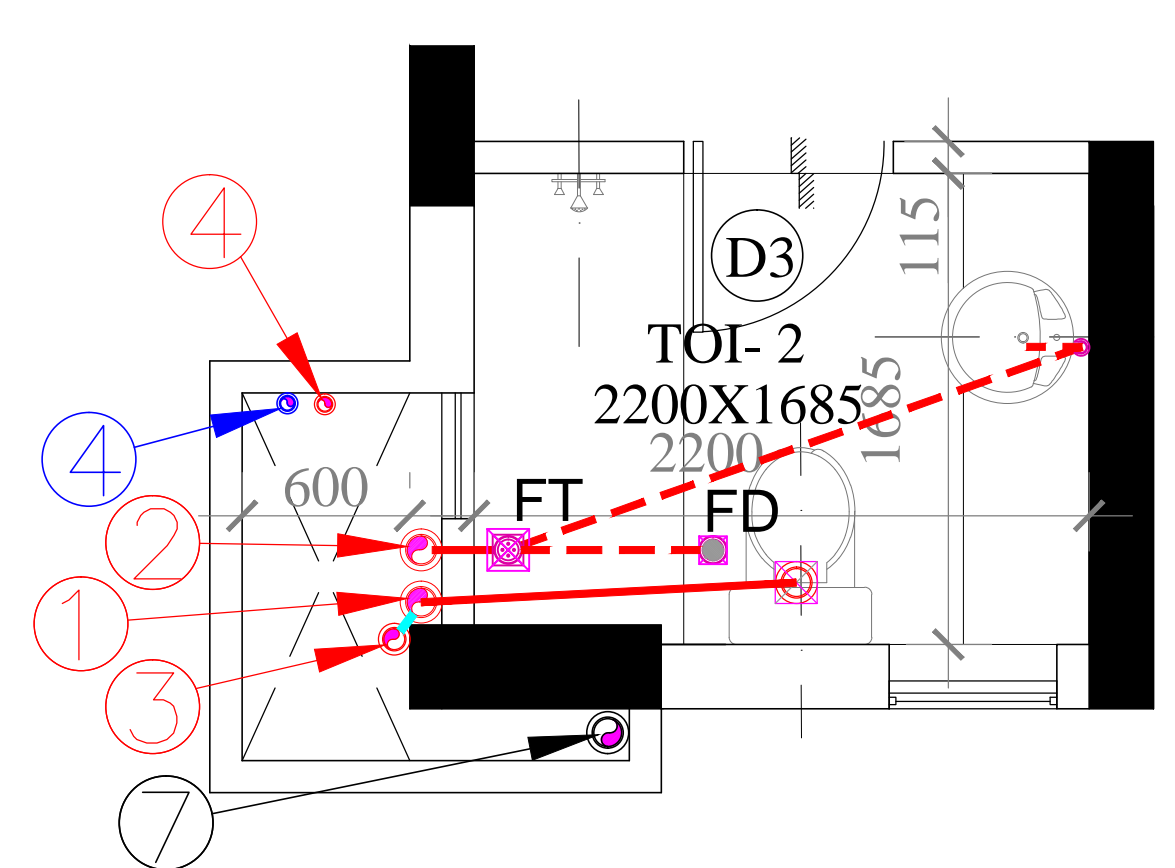


GROUND FLOOR PLAN FOR TYPICAL TOILET DETAIL (BLOCK - B1 & B3)

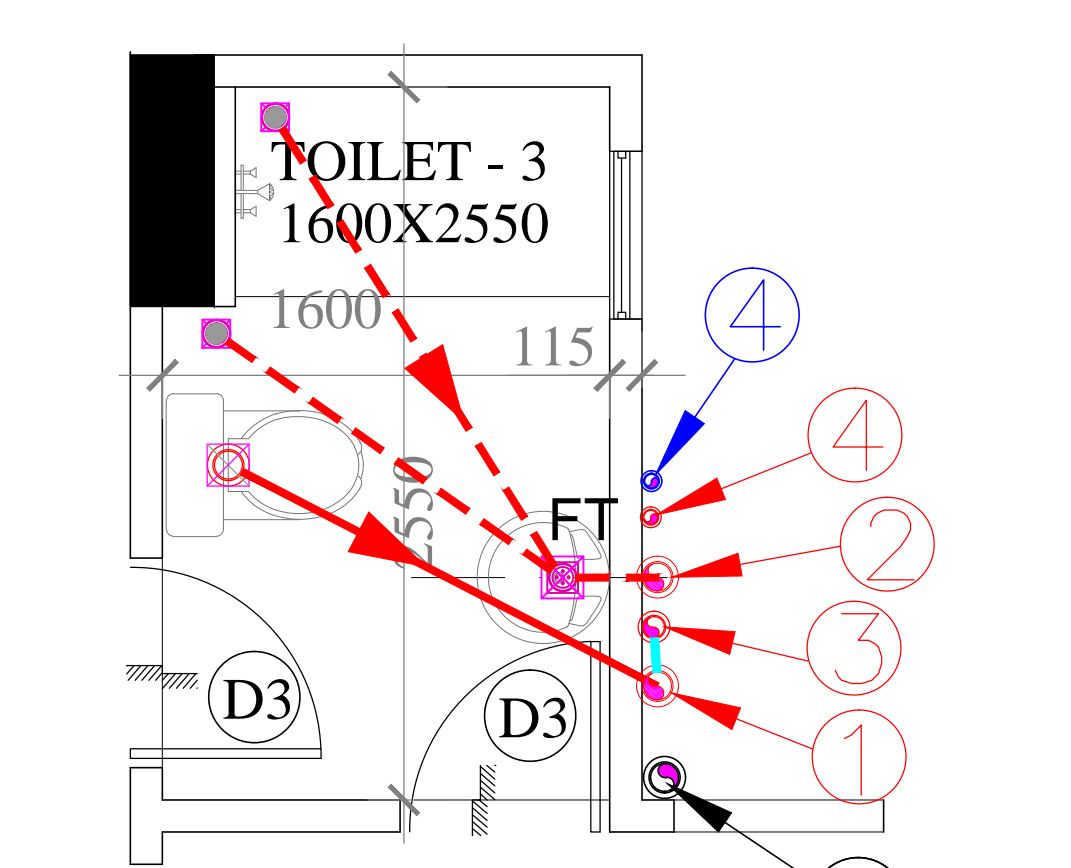


GROUND FLOOR PLAN FOR TYPICAL TOILET DETAIL (BLOCK - B1 & B3)

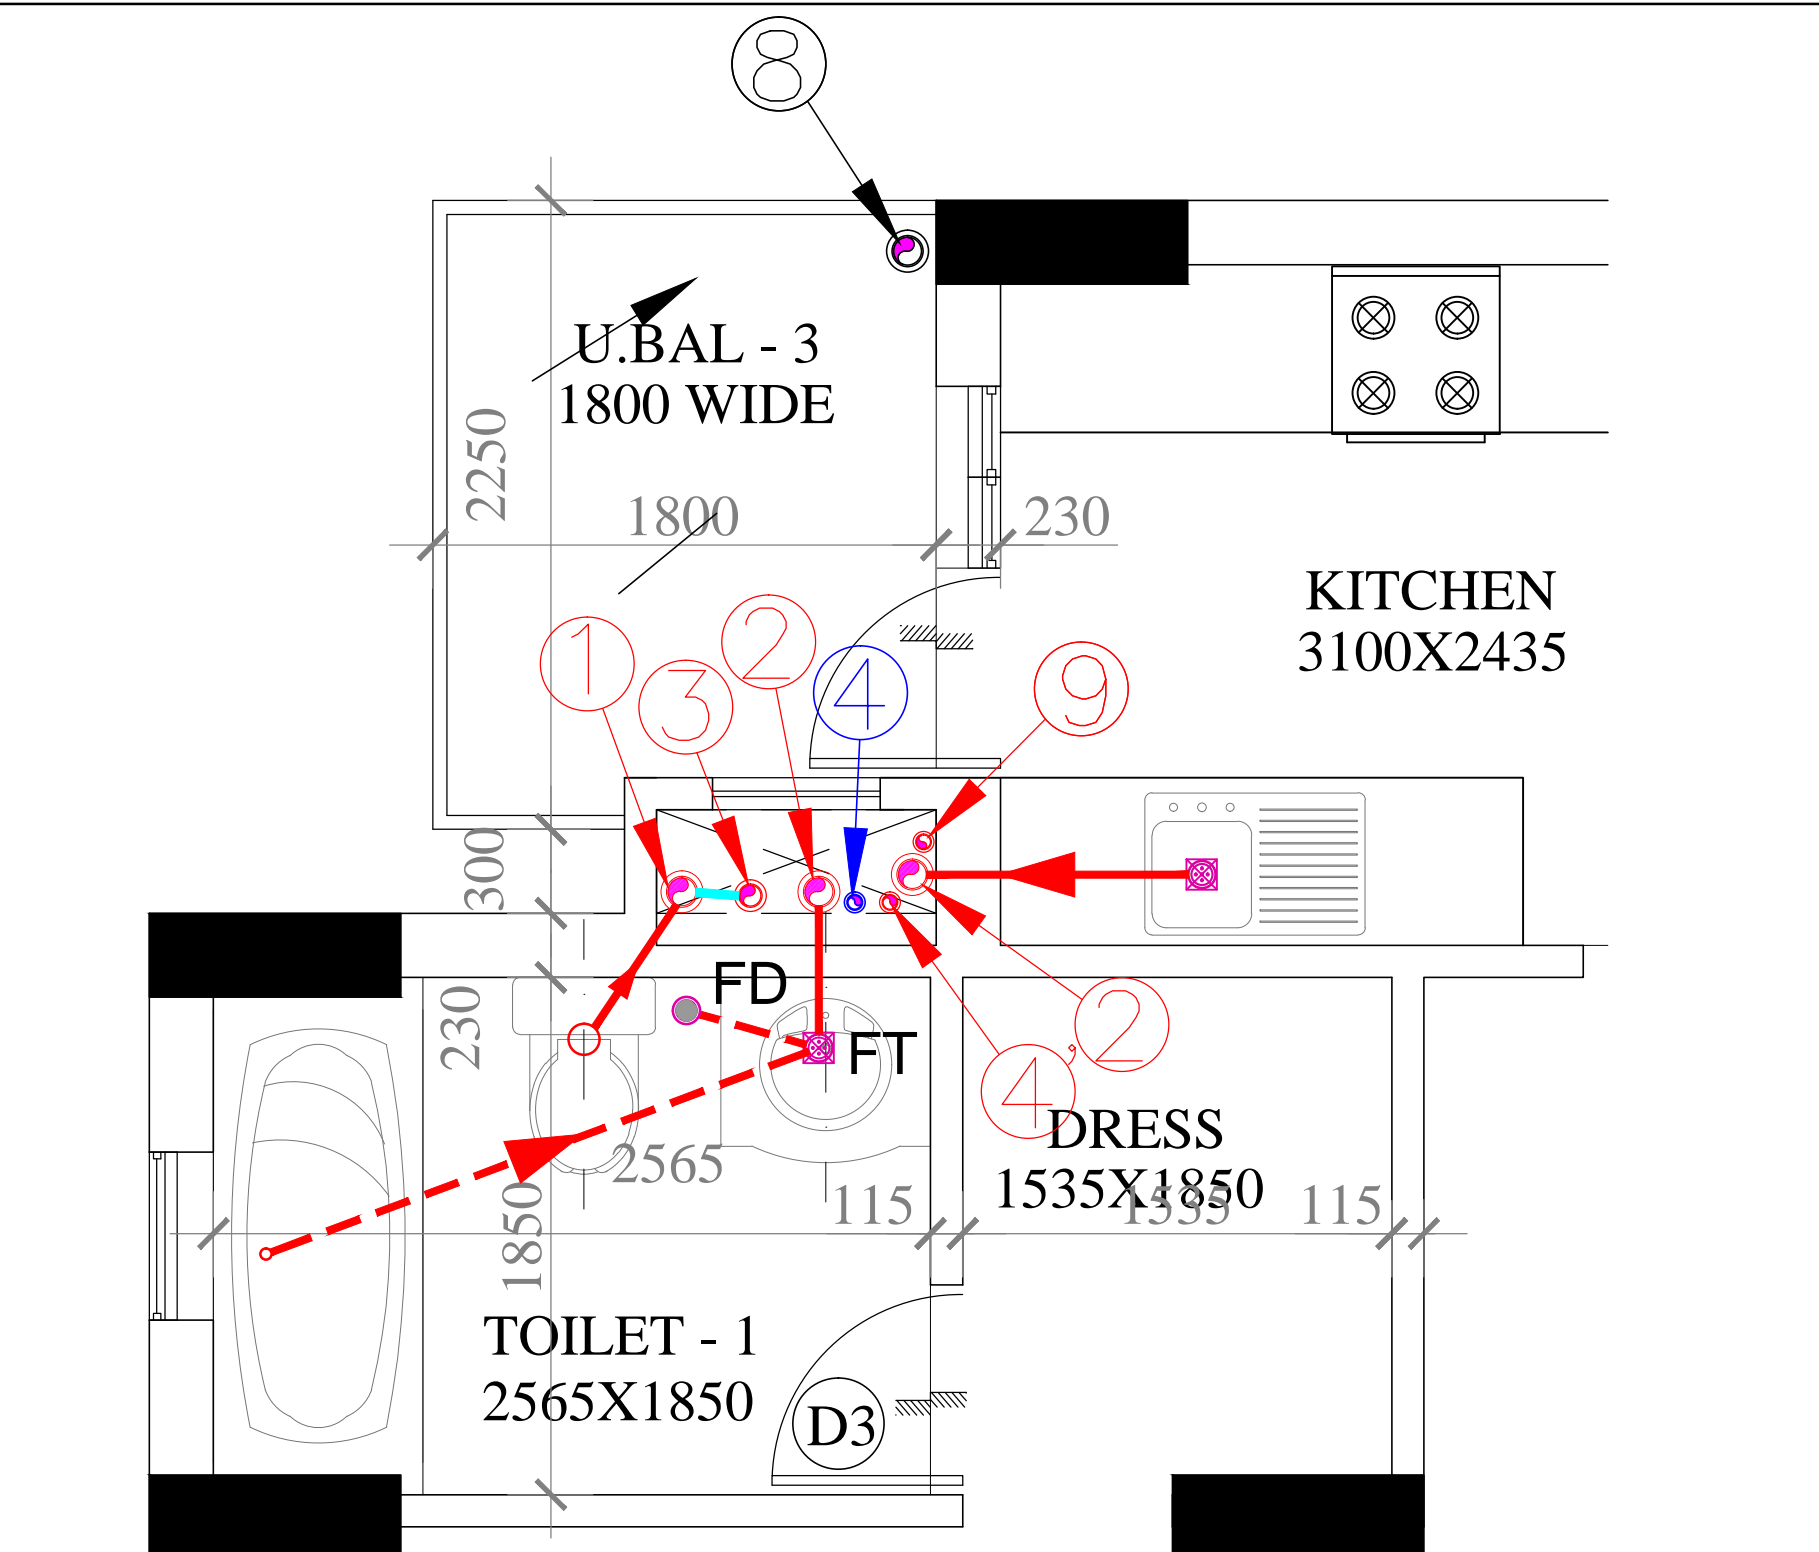


TYPICAL FLOOR PLAN (1ST TO 11TH FLOOR) FOR TOILET DETAIL (BLOCK - B1 & B3)

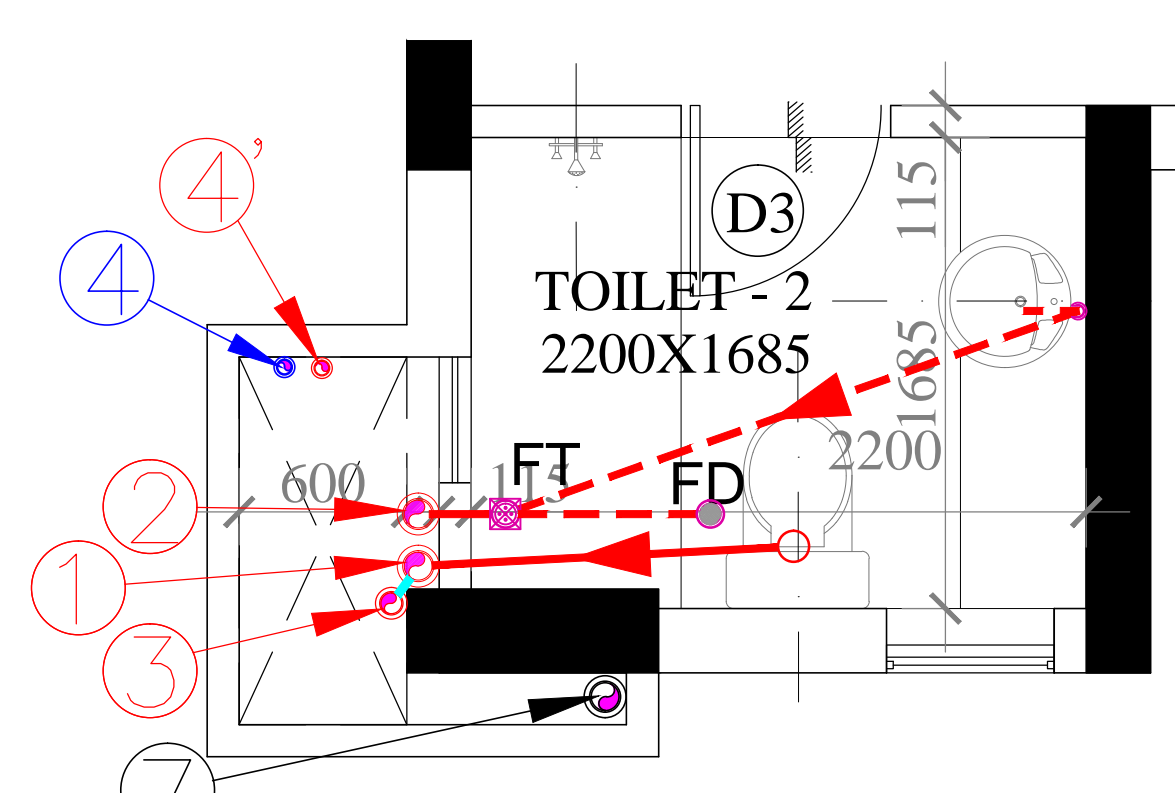


TYPICAL FLOOR PLAN (1ST TO 11TH FLOOR) FOR TOILET DETAIL (BLOCK - B1 & B3)

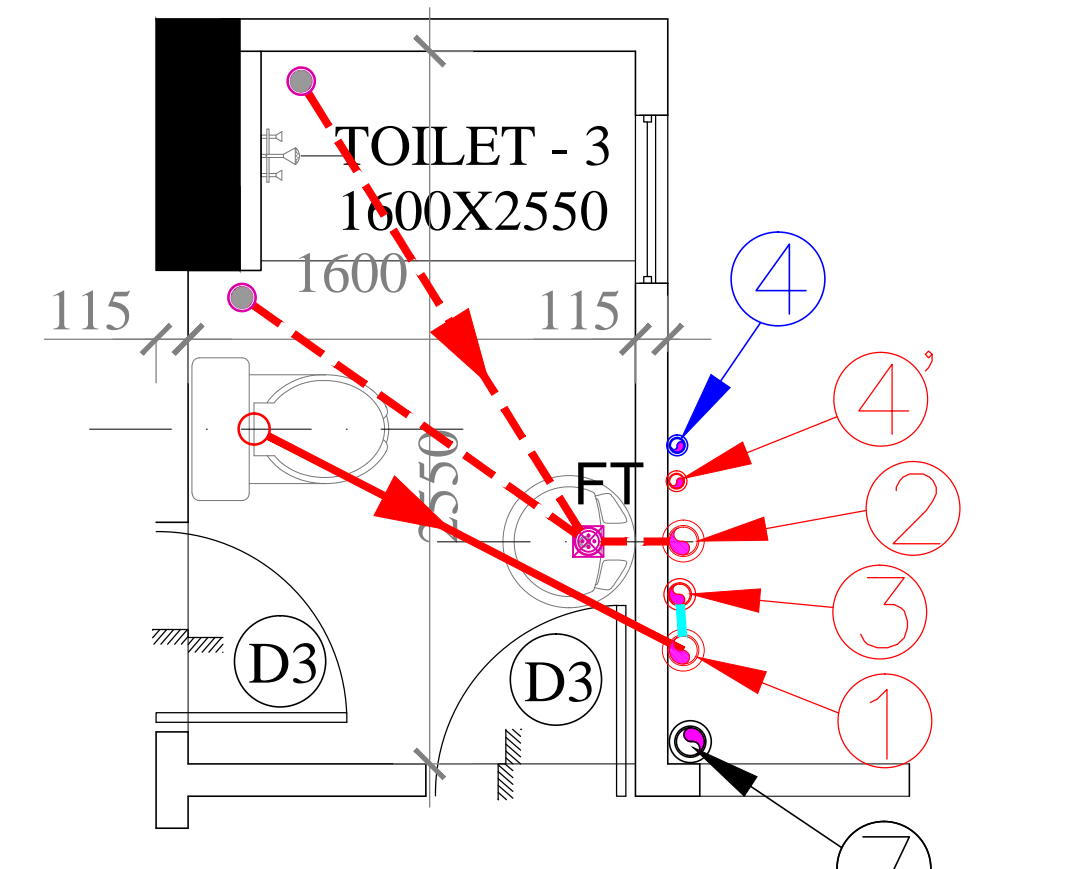


TYPICAL FLOOR PLAN (1ST TO 11TH FLOOR) FOR TOILET DETAIL (BLOCK - B1 & B3)

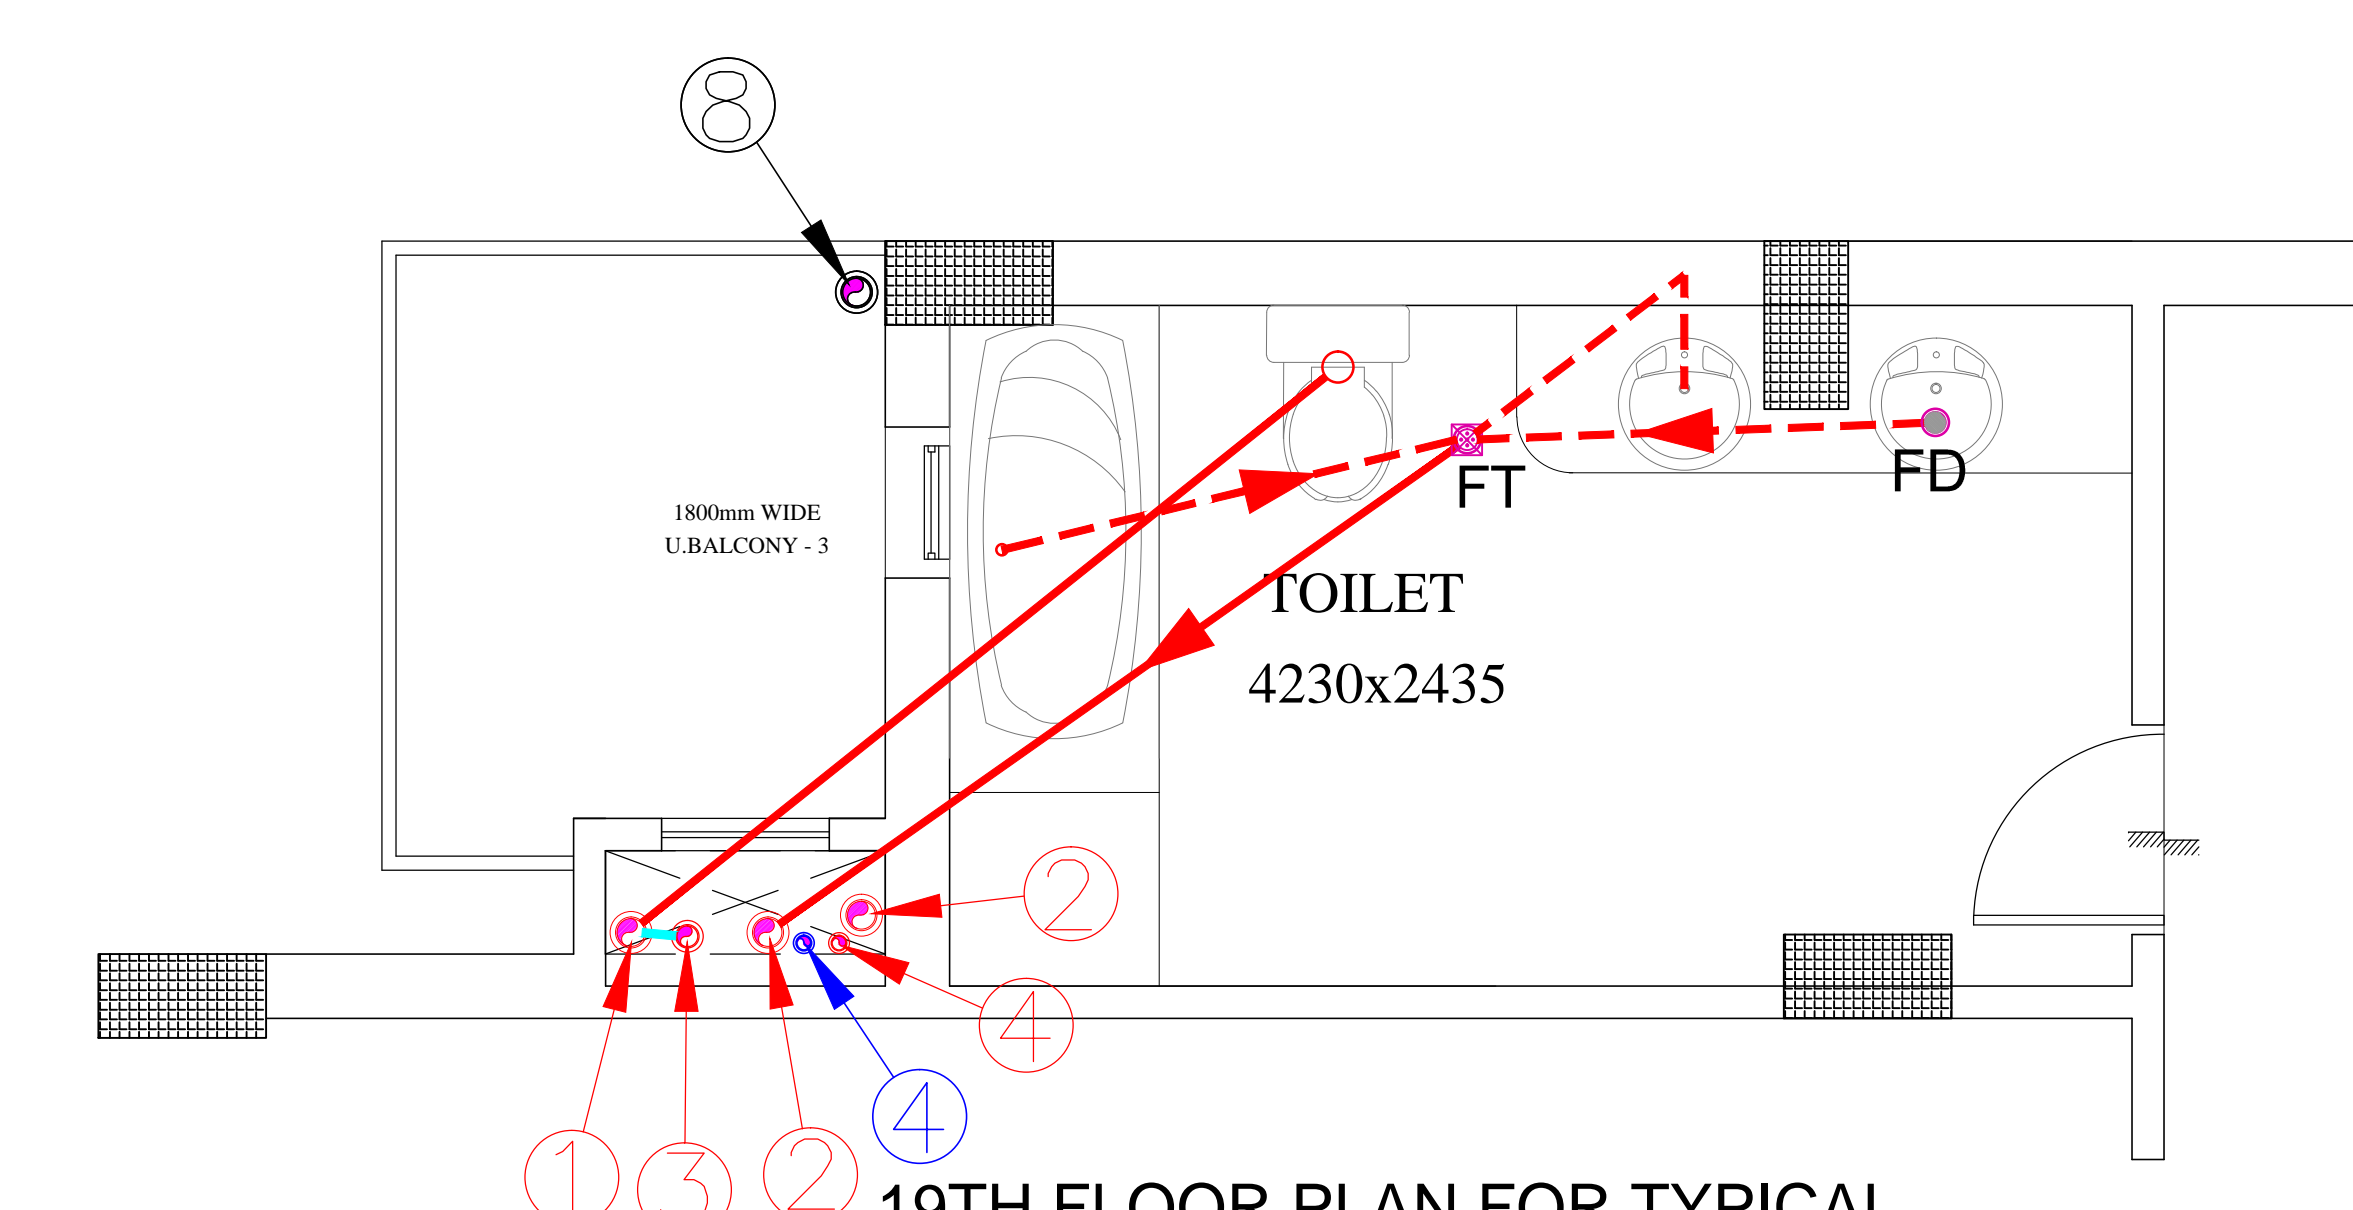


19TH FLOOR PLAN FOR TYPICAL TOILET DETAIL (BLOCK - B1 & B3)

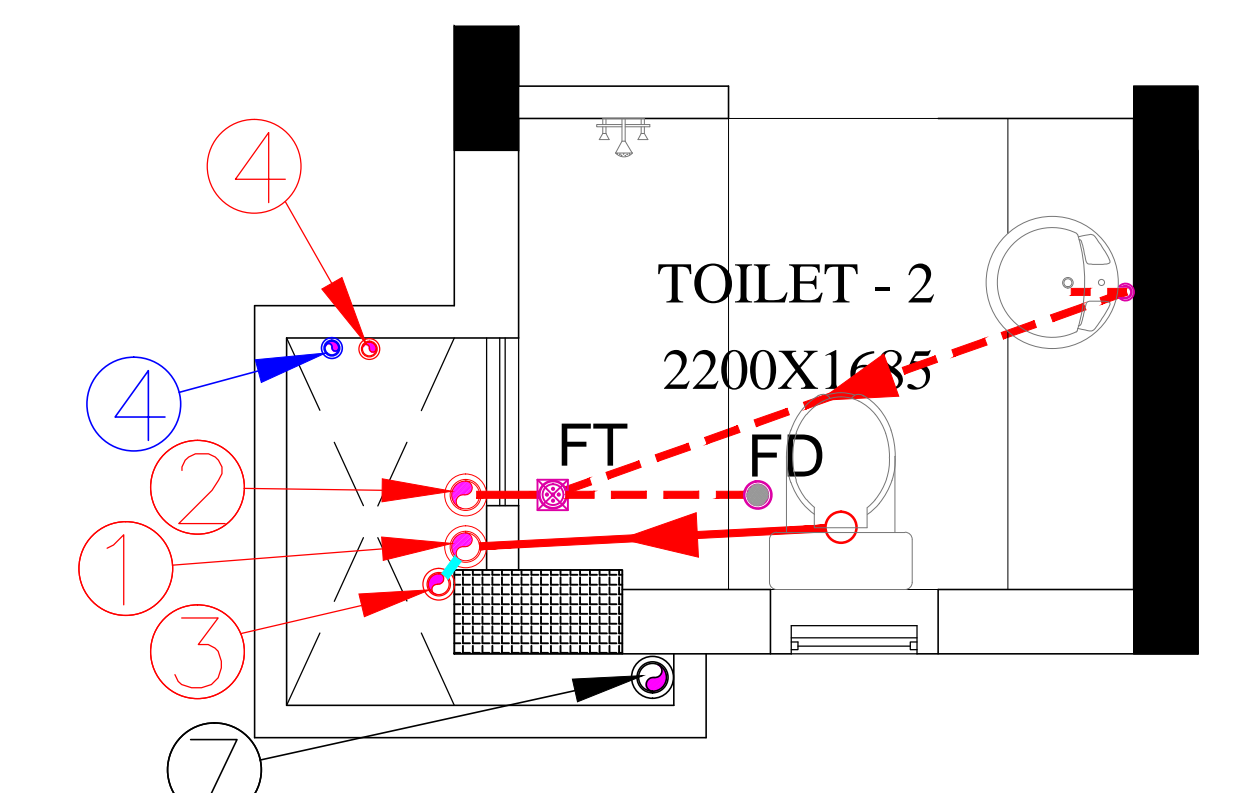

19TH FLOOR PLAN FOR TYPICAL TOILET DETAIL (BLOCK - B1 & B3)

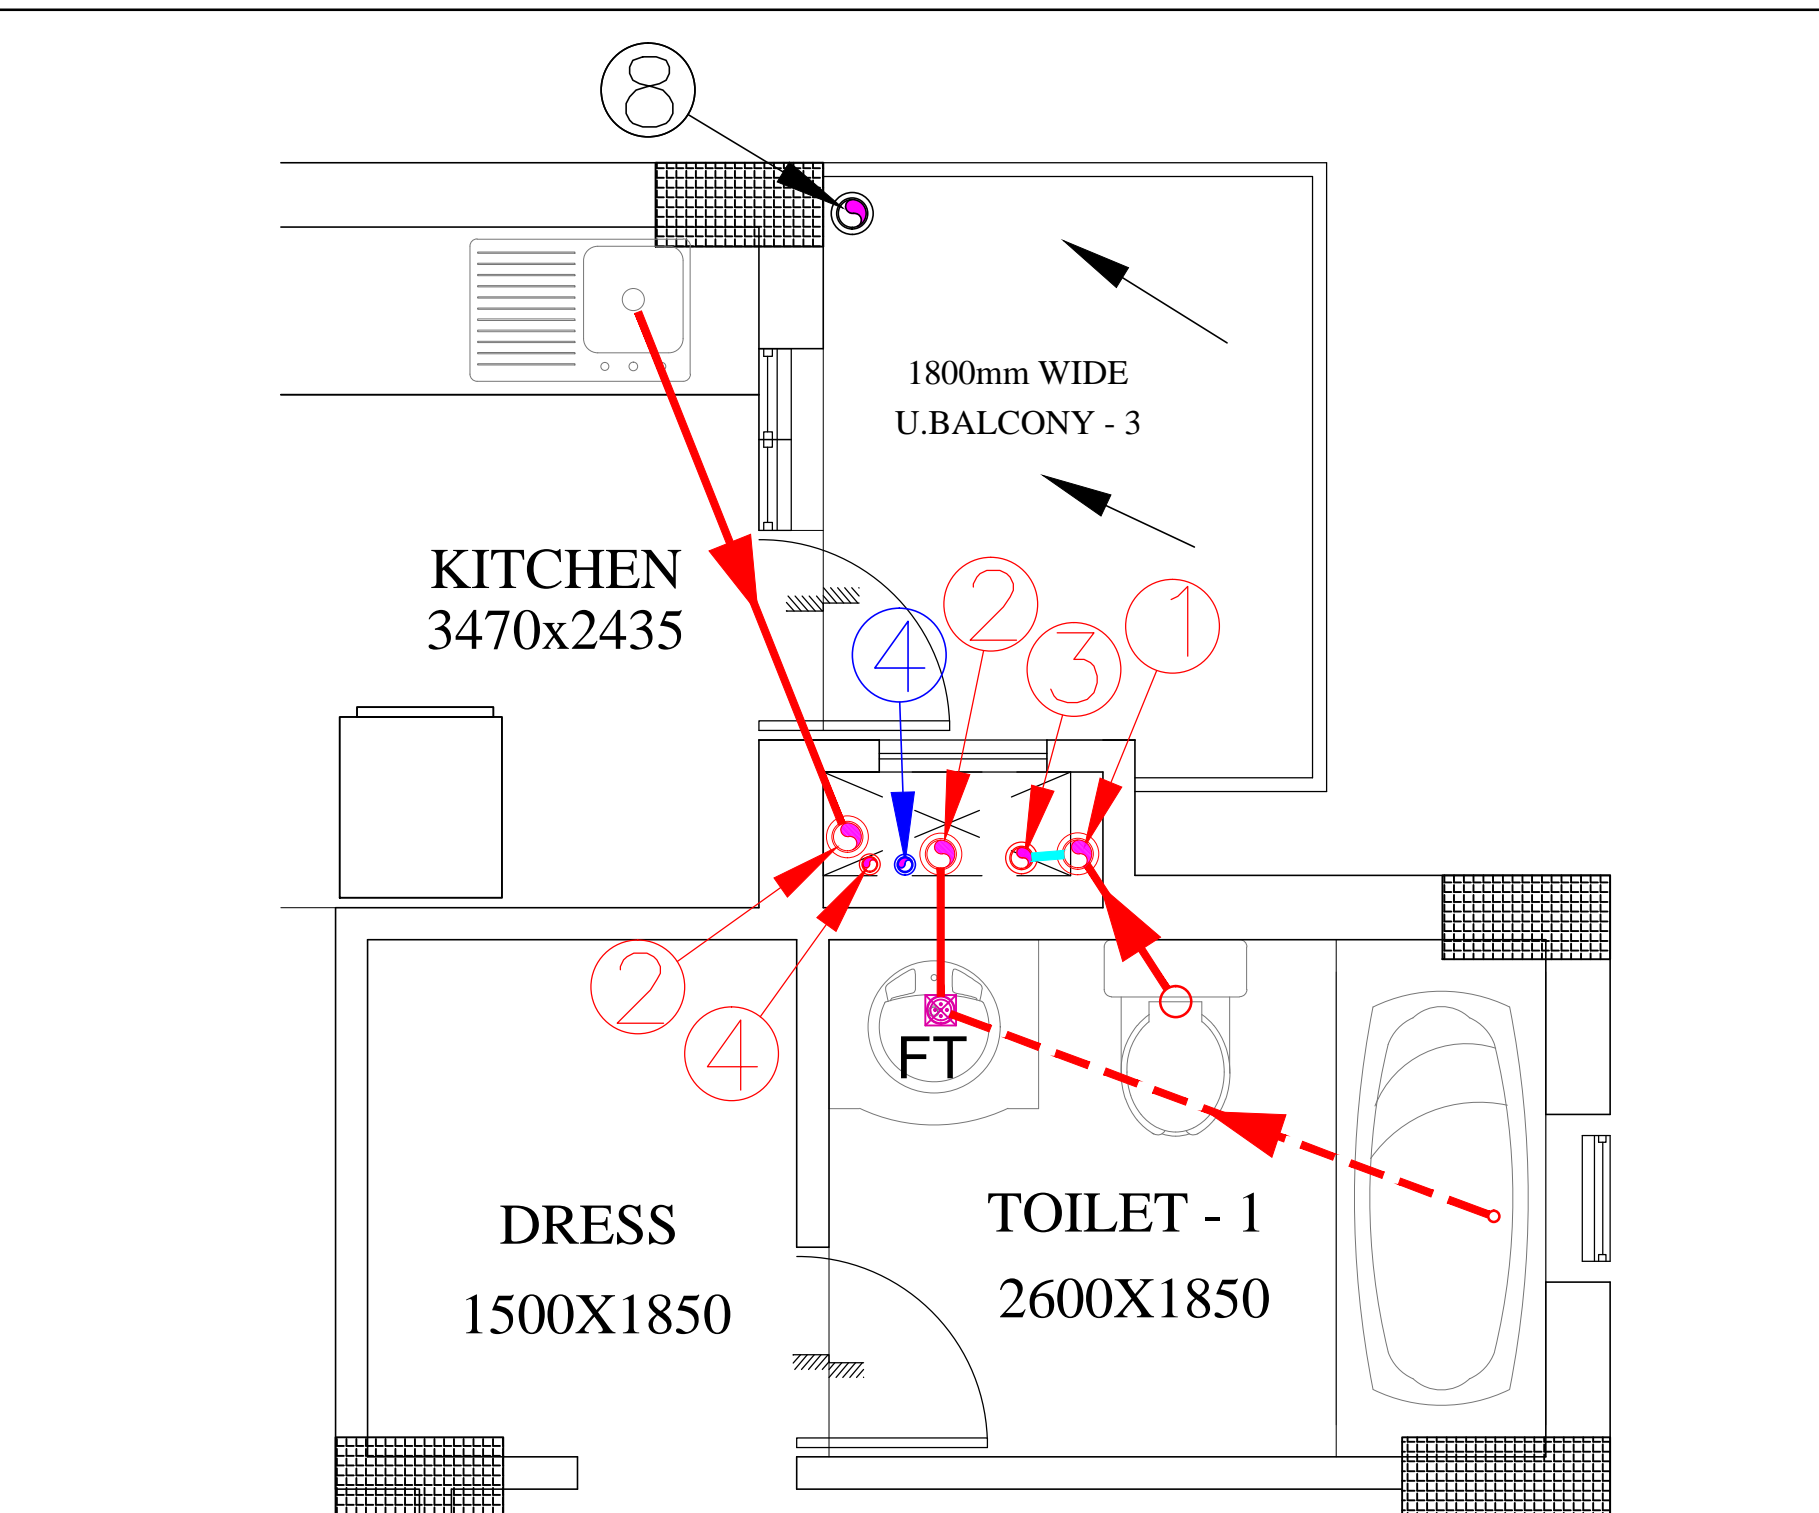

19TH FLOOR PLAN FOR TYPICAL TOILET DETAIL (BLOCK - B1 & B3)

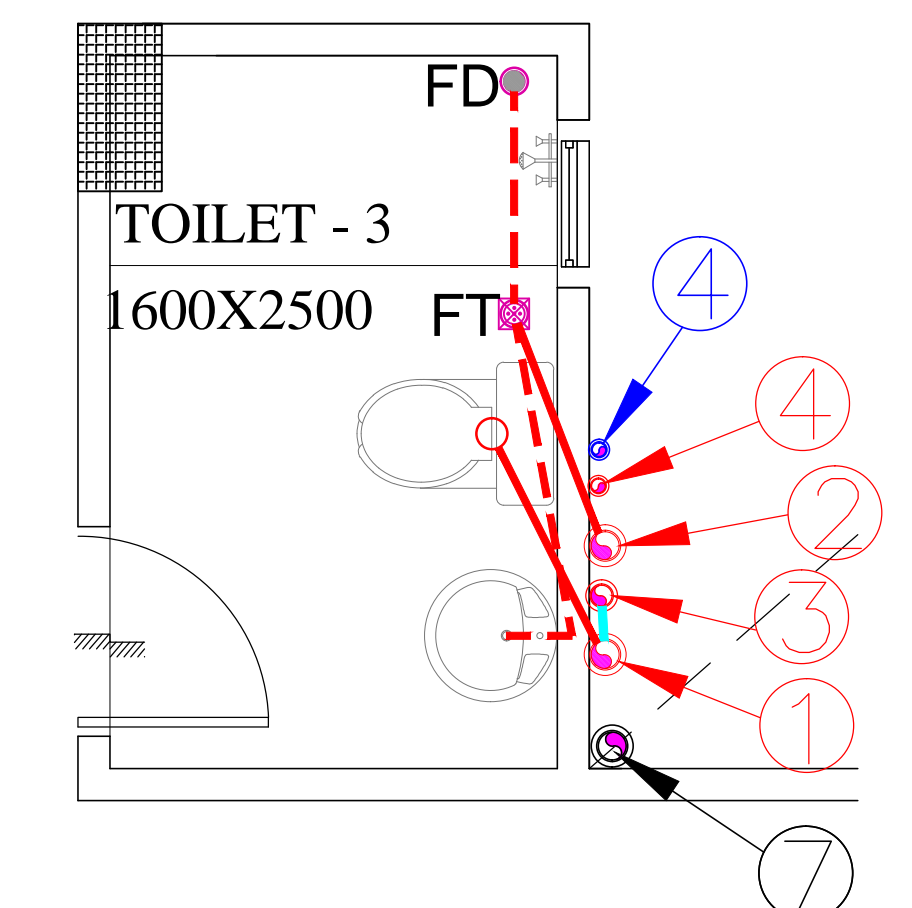

19TH FLOOR PLAN FOR TYPICAL TOILET DETAIL (BLOCK - B1 & B3)

LEGEND: -

PLUMBING LEGEND	
①	110ø OD uPVC SP STACK
②	110ø OD uPVC WP STACK
③	160ø OD uPVC WP STACK (ONLY KITCHEN)
④	75ø A.S.P
⑤	DWS D/TAKE
⑥	FWS D/TAKE
⑦	65ø DWS RISER
⑧	50ø FLUSHING RISER
⑨	110ø OD uPVC R.W.P
⑩	75ø uPVC DRAIN PIPE (BALCONY)
⑪	SOLAR HOT WATER SUPPLY D/TAKE

LEGEND: -

SYMBOL	DESCRIPTION
—	SOIL PIPE
—	WASTE PIPE
⊙	FT
⊙	FLOOR TRAP
⊙	CUTOUT
⊙	FLOOR DRAIN

OWNER'S SIGN	ARCHITECT'S SIGN
PROJECT: PROPOSED GROUP HOUSING COLONY MEASURING 19.362 ACRE LICENSE NO. - 85 OF 2008, DATED 11.04.08 IN SECTOR-82, GURGAON MANESAR URBAN COMPLEX.	
CLIENT: M/S. SPEAR DEVELOPERS PVT.LTD & OTHERS.	
TYPE 'A & B FOR PLUMBING SUBMISSION	TOWER A & B FLOOR PLAN TOILET DETAIL
ARCHITECTS: GIAN P. MATUR & ASSOCIATES PVT. LTD. ARCHITECTS, ENGINEERS AND PLANNERS C-55, EAST OF KARLAH NEW DELHI - 110065 PH- 011-45599599	
SCALE: 1:50	DWG. NO.: